


Single Line Diagram 150/20 kV Gardu Induk Teluk Betung

PT PLN (Persero) P3B SUMATERA
UPT TANJUNG KARANG

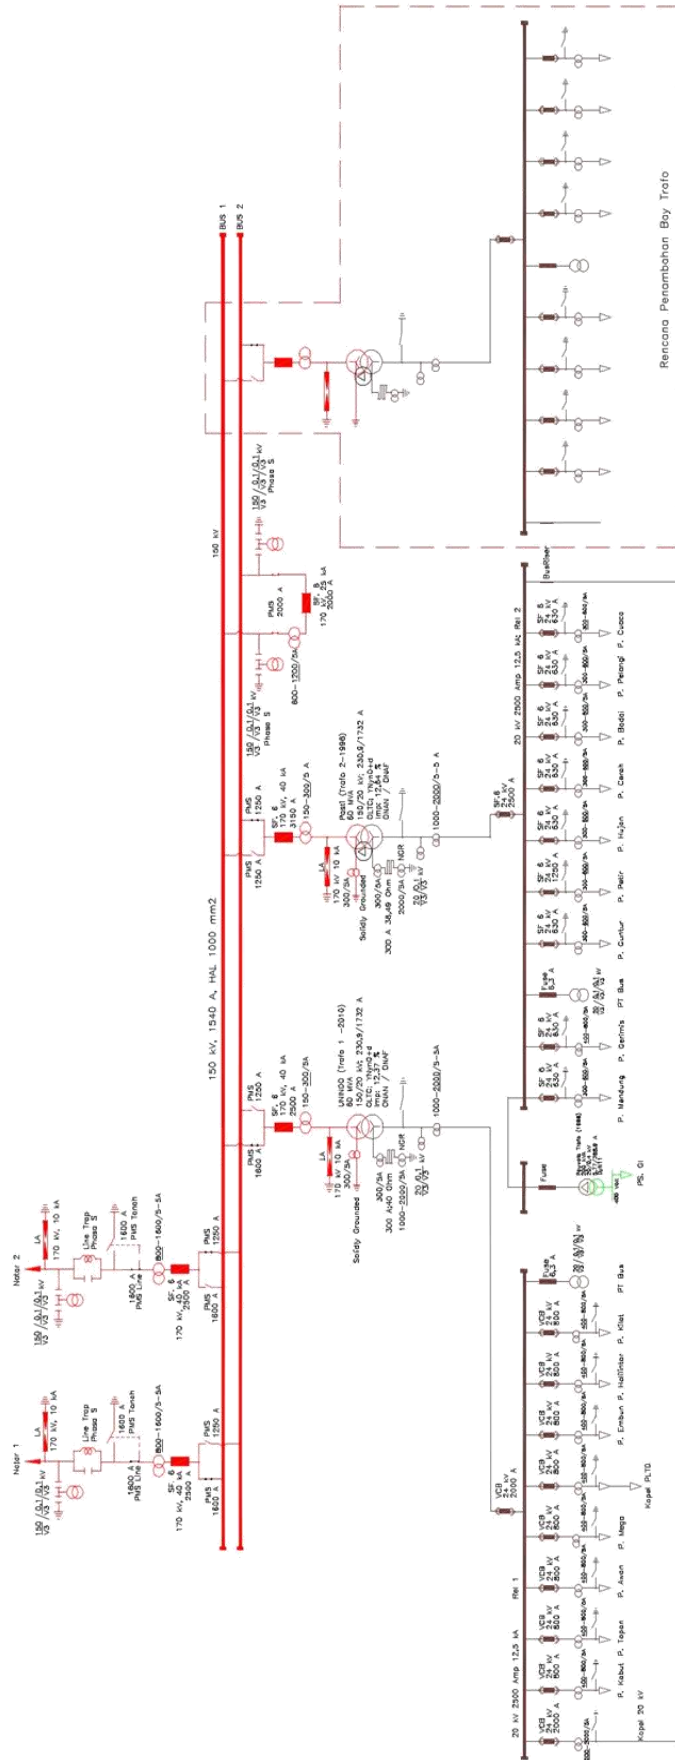

Disambar	: Mursid L N	Keterangan	:
Diperiksa	: Inda P		
Diketahui	: Idhamsyah K		AS BUILT DRAWING
Disetujui	: Ika Sudarmaja		
SINGLE LINE DIAGRAM SISTEM			
150/20 kV Gardu Induk Teluk Betung			
PT PLN (Persero) P3BS		REV	DWG NO: SLD-3215-081-04
UPT TANJUNG KARANG		1.0	Agustus 2015