



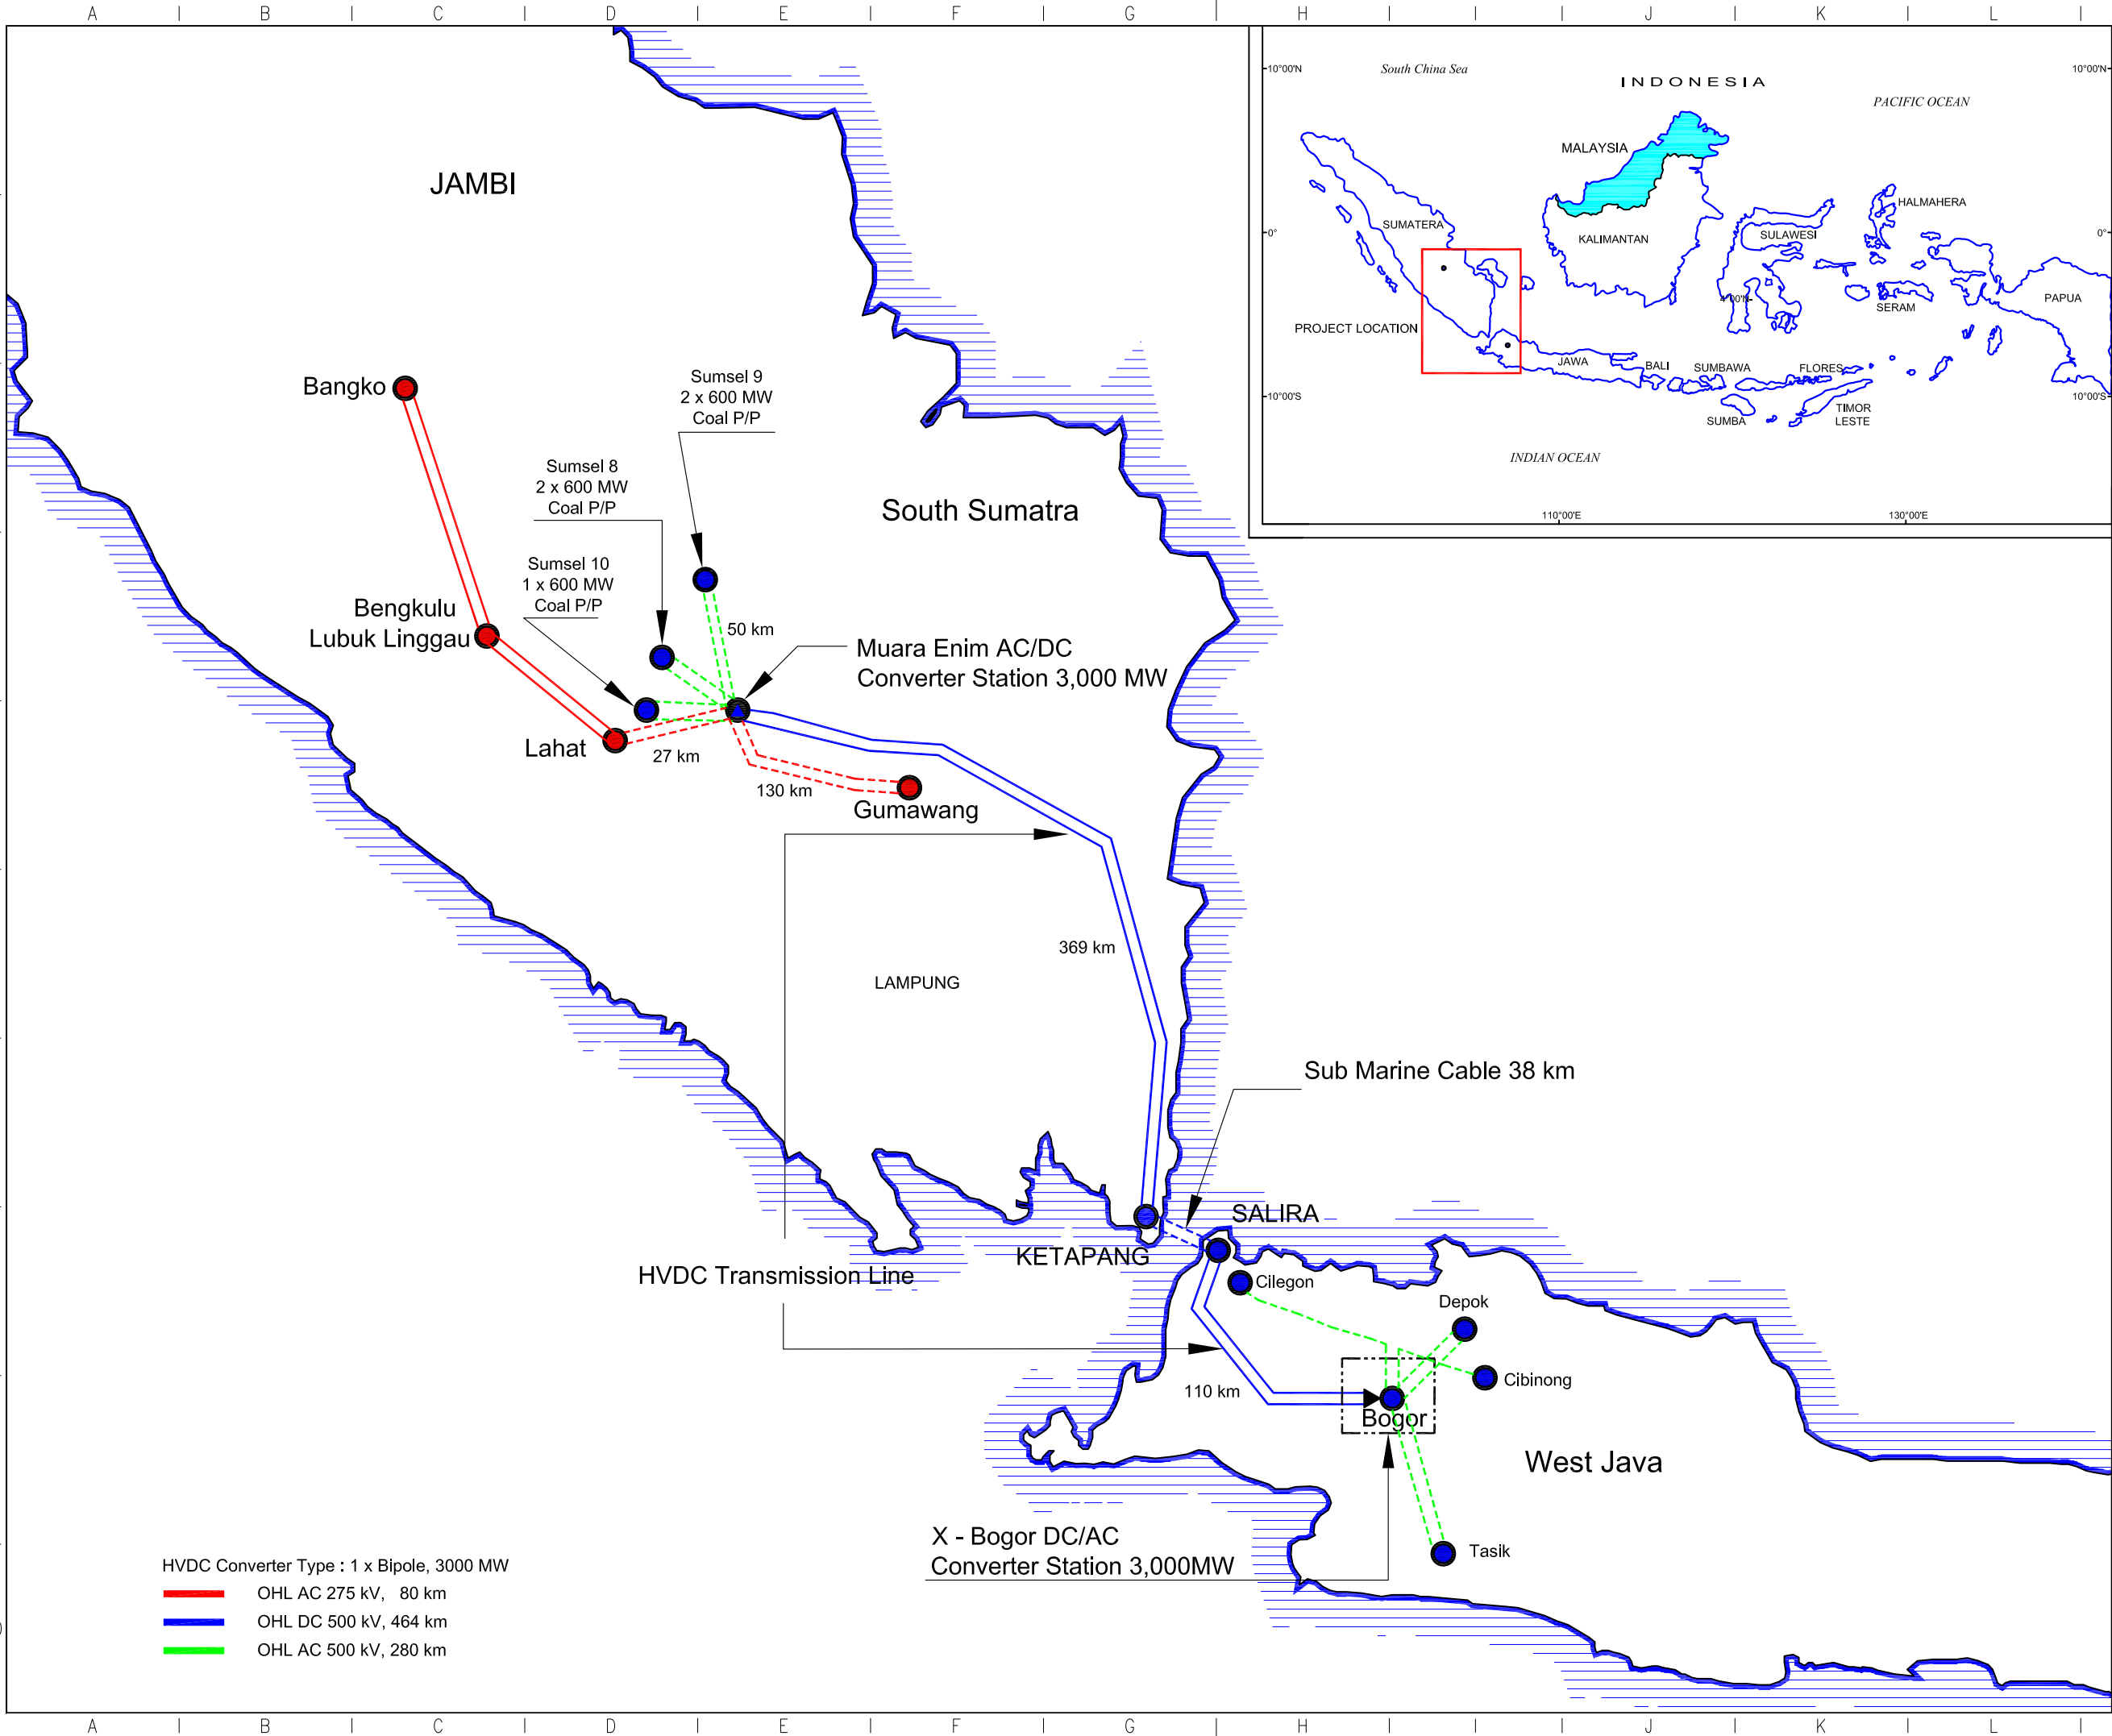

REV.	DESCRIPTION	DATE	DRAWN	CHK'D	APP'D
OWNER					
 PT. PLN (Persero)					
CONSULTANT					
  					
PROJECT					
 JAVA - SUMATRA INTERCONNECTION TRANSMISSION LINE PROJECT JICA ODA LOAN NO. IP - 555					
TITLE					
Project Location					
DWG SIZE:	DATE	DRAWN	CHECKED	APPROVED	
A3	17-06-11	-	-	-	
SCALE:	DRAWING NO.:	SHEET:	REV.:		
NTS	P1-Pro-01	1 of 1			

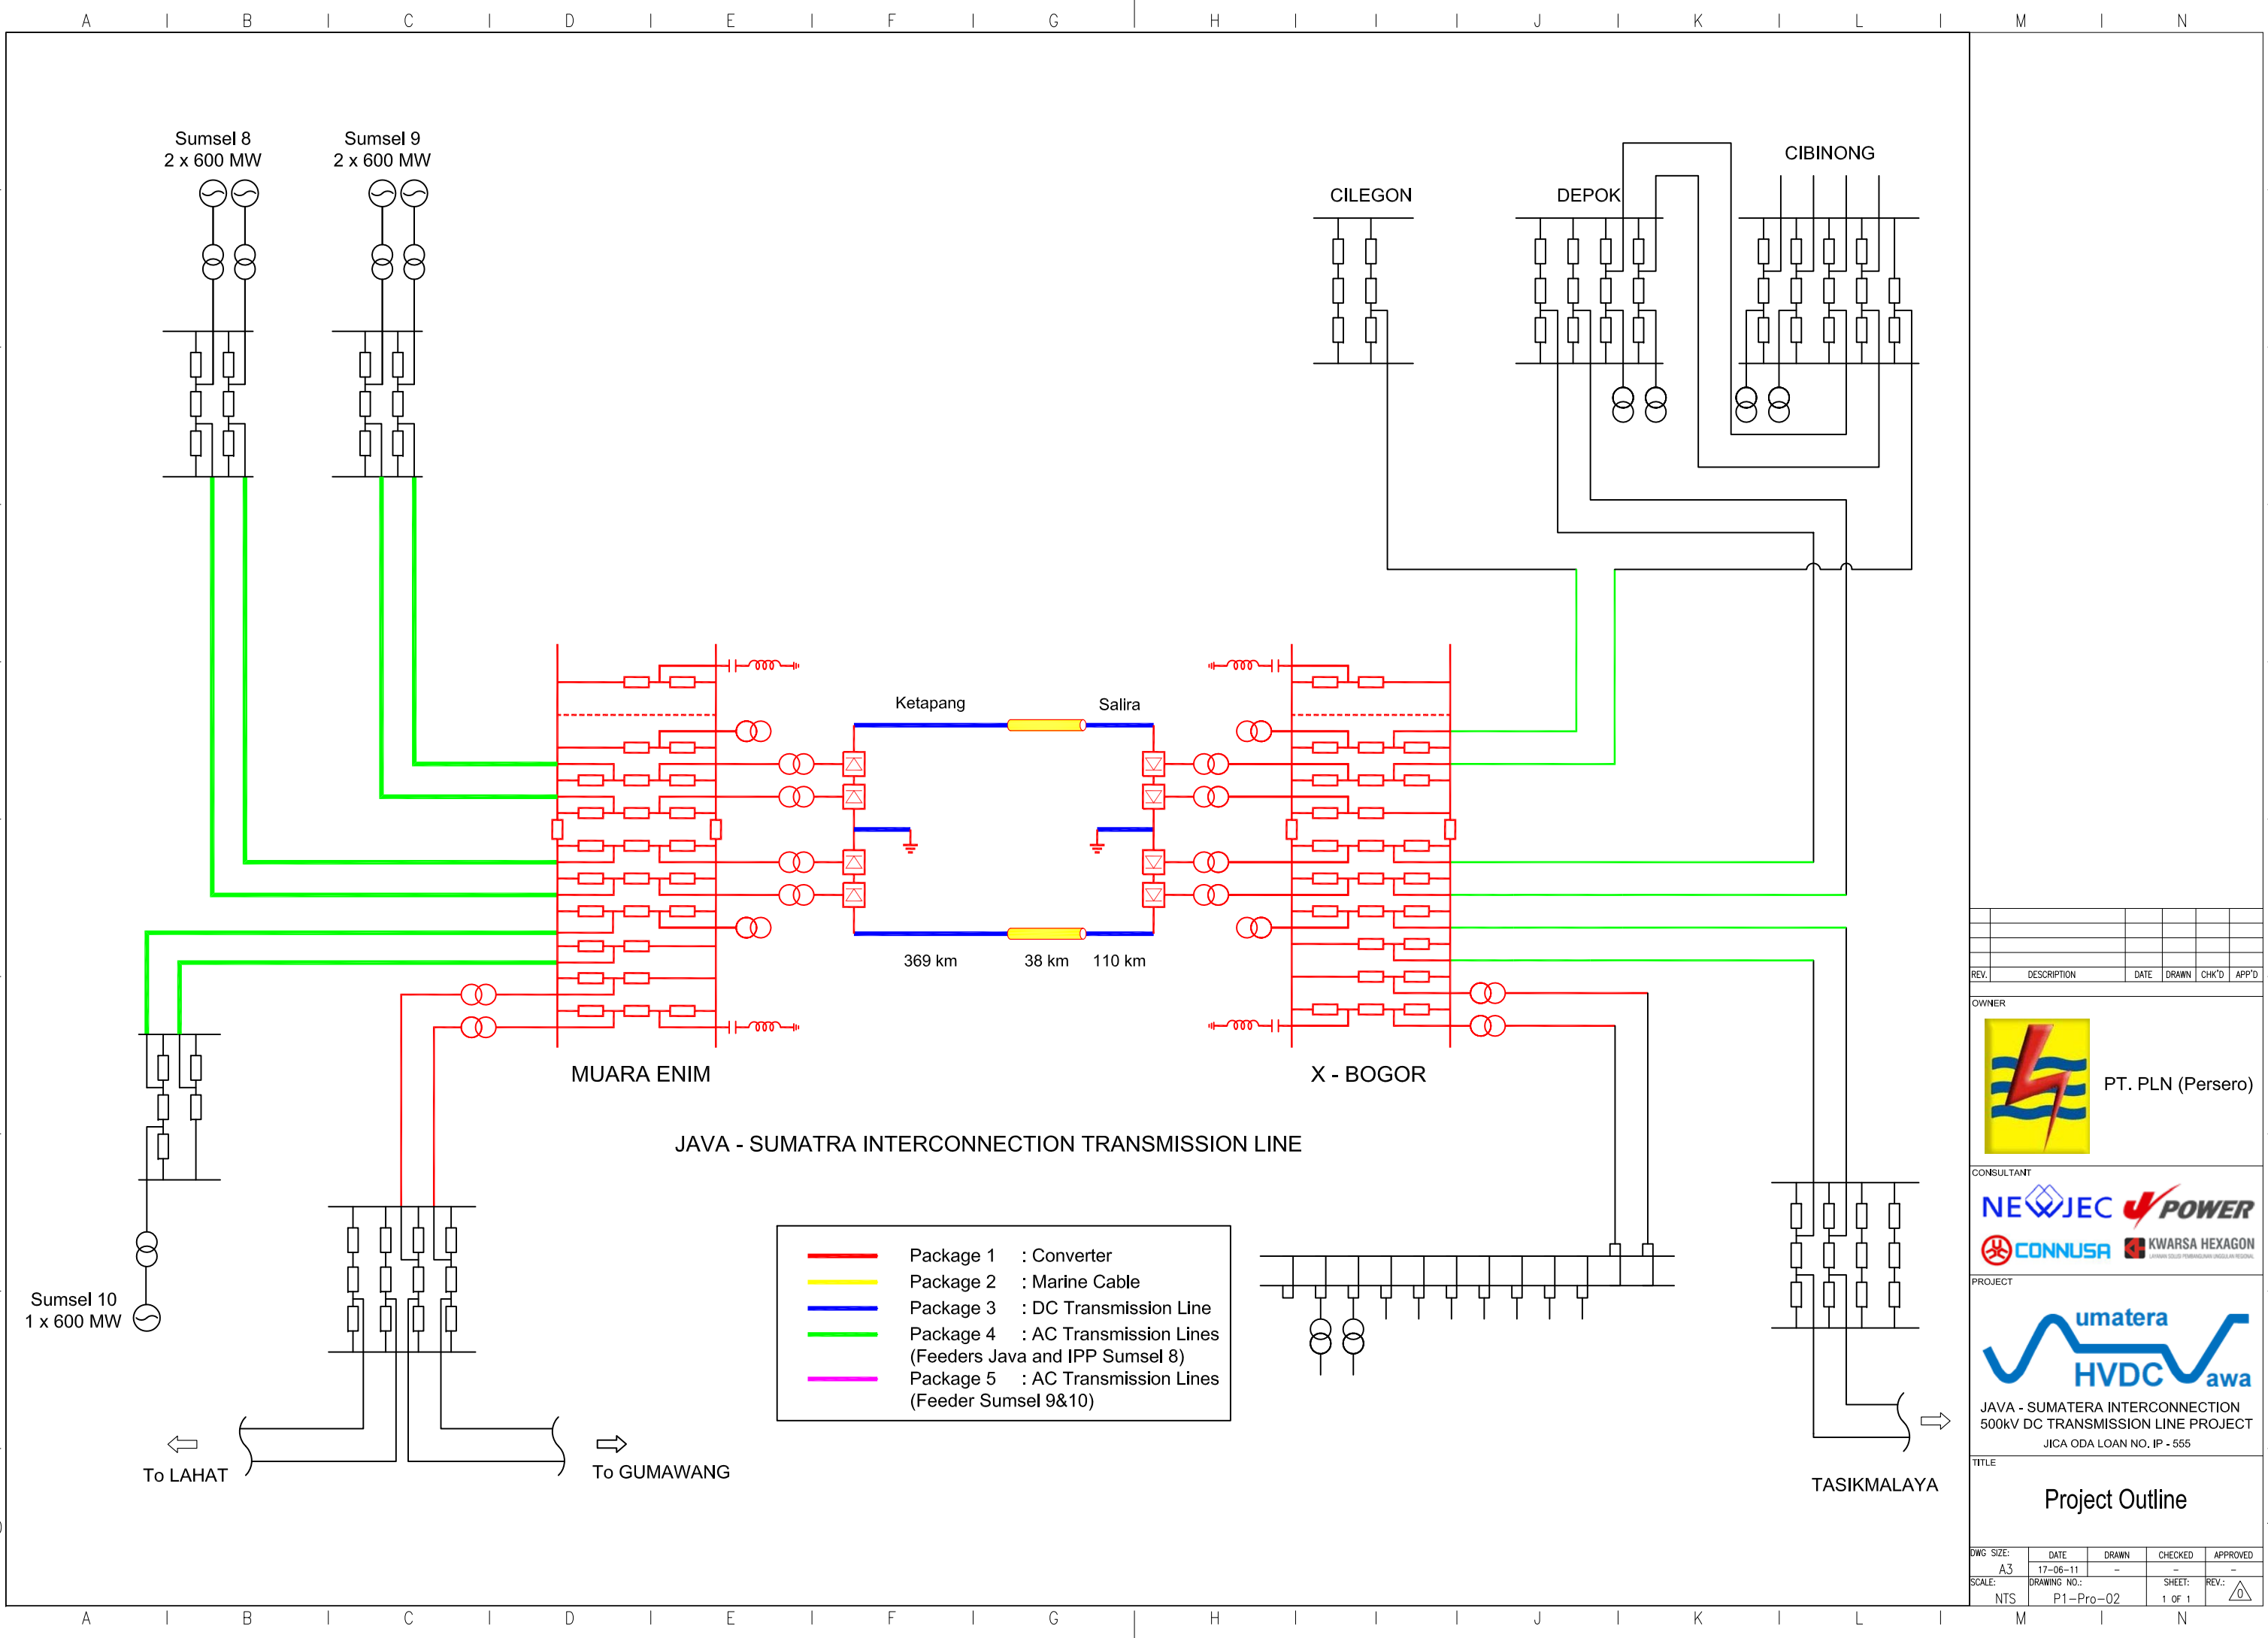

REV.	DESCRIPTION	DATE	DRAWN	CHK'D	APP'D

OWNER



PT. PLN (Persero)

CONSULTANT



PROJECT




umatera
HVDC
awa

JAVA - SUMATRA INTERCONNECTION
500kV DC TRANSMISSION LINE PROJECT
JICA ODA LOAN NO. IP - 555

TITLE

Project Outline

DWG. SIZE:	DATE	DRAWN	CHECKED	APPROVED
A3	17-06-11	-	-	-
SCALE:	DRAWING NO.:	SHEET:	REV.:	
NTS	P1-Pro-02	1 OF 1		

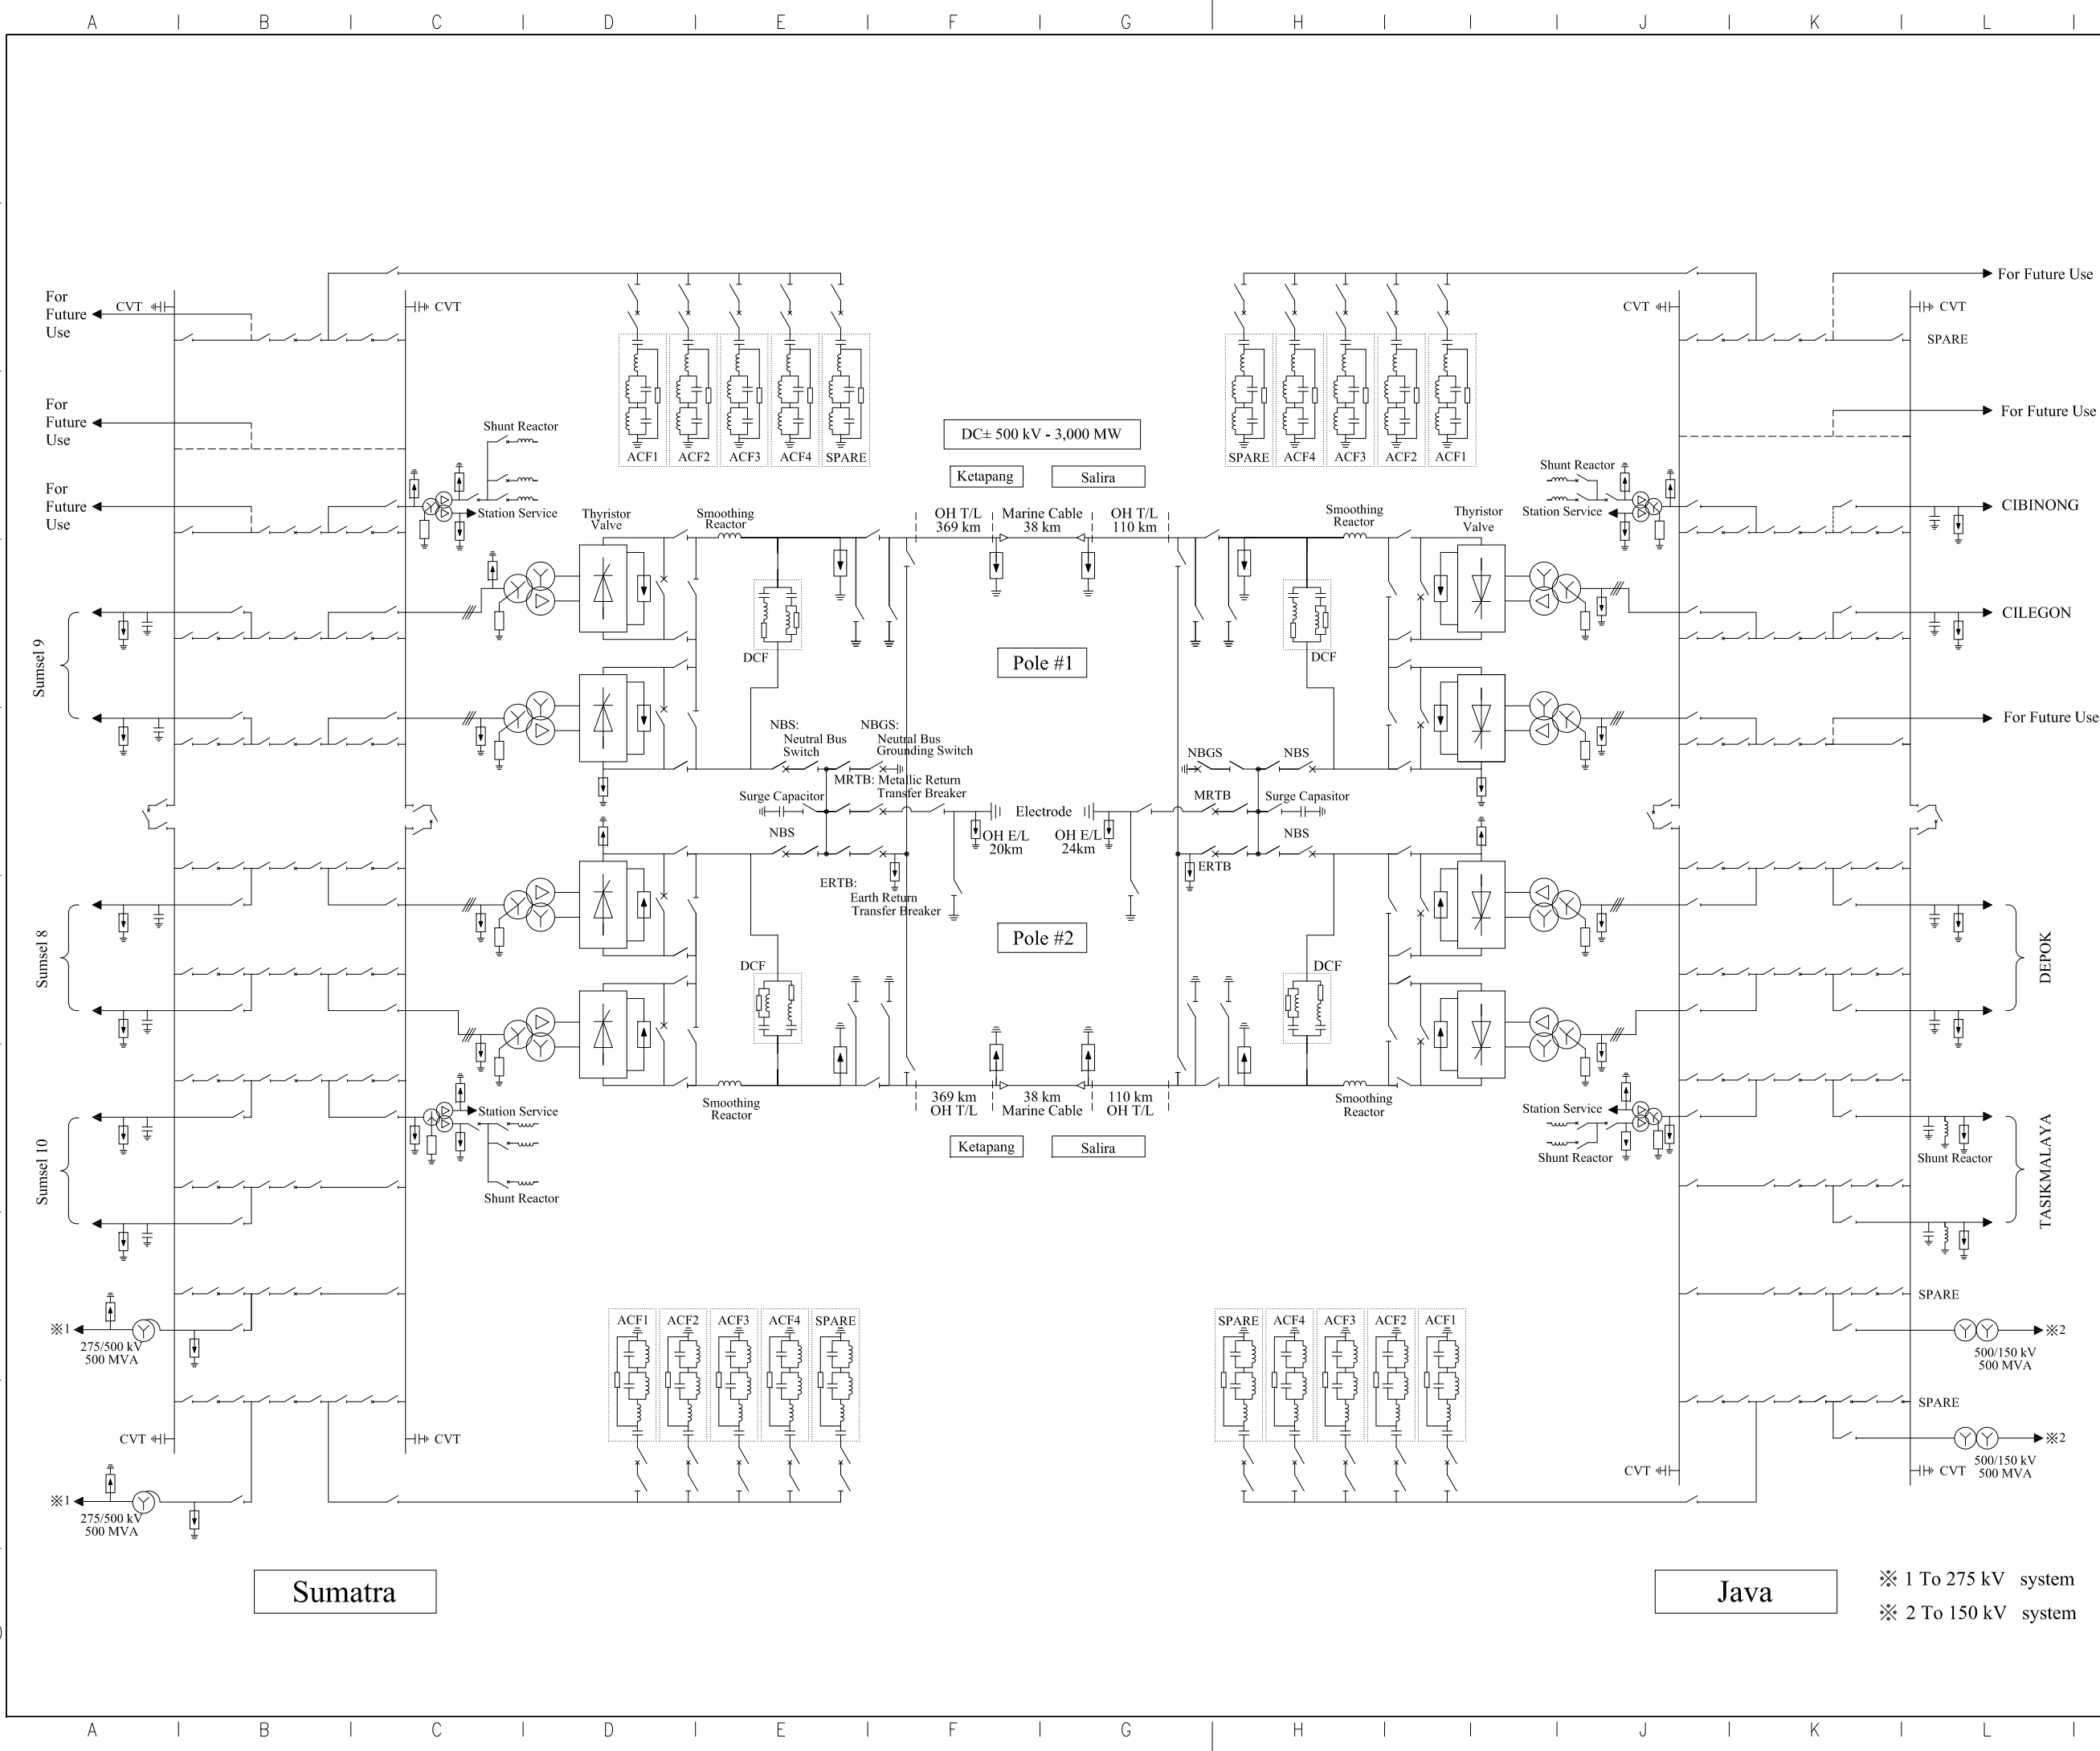

REV.	DESCRIPTION	DATE	DRAWN	CHK'D	APP'D

OWNER

 **PT. PLN (Persero)**

CONSULTANT

 **NEJEC POWER**

 **CONNUSA**  **KWASA HEXAGON**

PROJECT

 **umatera HVDC awa**

JAVA - SUMATRA INTERCONNECTION
TRANSMISSION LINE PROJECT
JICA ODA LOAN NO. IP - 555

TITLE

**Single Line Diagram
of HVDC System**

DWG. SIZE:	DATE	DRAWN	CHECKED	APPROVED
A3	21-11-13	-	-	-

SCALE:	DRAWING NO.:	SHEET:	REV.:
NTS	P1-Conv-03	1 OF 1	△